


### KEY

- MDH MAGNETIC DOOR HOLDER
- 3H FIRE ESCAPE SIGNAGE
- SD SMOKE DETECTOR
- EL EMERGENCY LIGHTING
- 9W 9 LITRE WATER FIRE EXTINGUISHER
- 2C 2 KG CO2 FIRE EXTINGUISHER

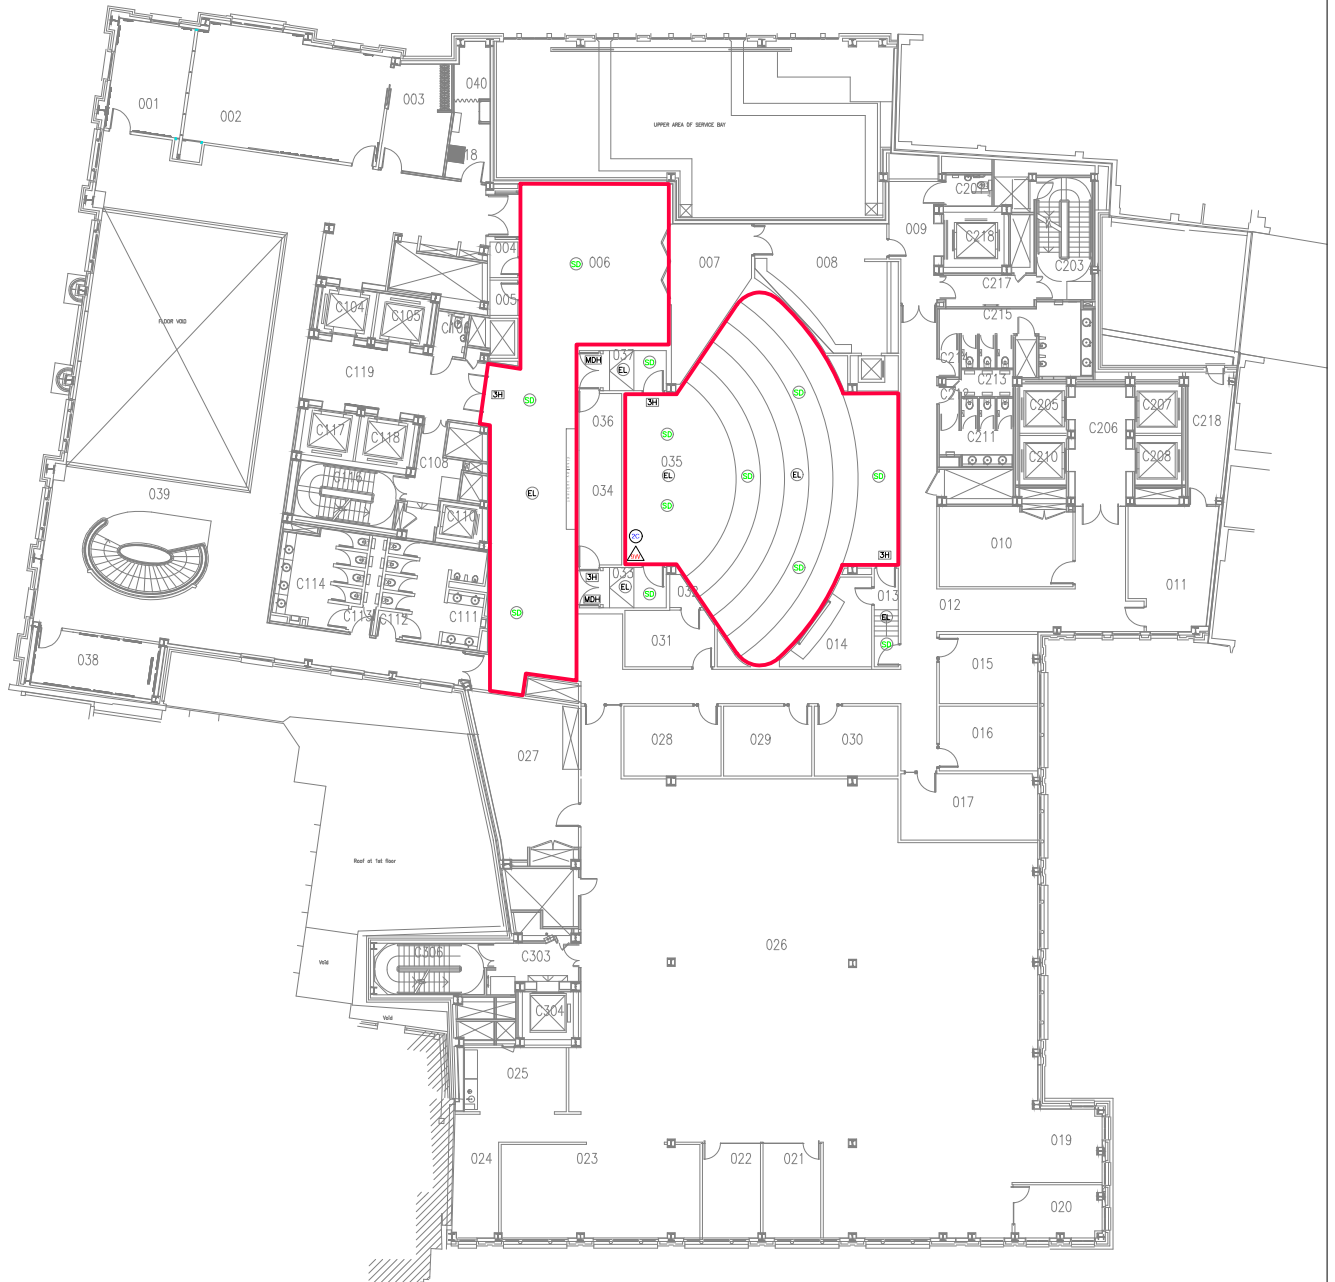

Project:

Title: **First Floor Plan  
Existing**

Dept/Team:

Date: 24:04:13 Scale: 1:250 @ A3

Floor Zone Project No. Dwg Stage Dwg No. Rev

MG1 - OA - EX - 01 -

